


Symbol	Qty	Label	Arrangement	LFP	Description
24	1	A (Car Park)	SINGLE	0.900	15w LED 4000k (4 module) 700mA labe 1 with 505 Optic column mounted at 6m
31	1	B (Perimeter Fence)	SINGLE	0.900	58w LED 4000k (3 module) 700mA labe 1 with 505 Optic column mounted at 6m
32	1	B2 (Perimeter Fence)	TWIN 25 DEGREE	0.900	2 x 30.5w LED 4000k (2 module) 525mA labe 1 with 305 Optic column mounted at 6m
14	1	B3 (Car Park)	BACK-2-BACK	0.900	2 x 58w LED 4000k (2 module) 700mA labe 1 with 505 Optic column mounted at 6m
112	1	C (House Blocks)	SINGLE	0.900	58.5w LED 4000k Via City Flood 585mA with FW70 Optic mounted on top of house blocks at 12.5m
88	1	D (Fence)	SINGLE	0.900	30.5w LED 4000k (2 module) 525mA labe 1 with 305 Optic column mounted at 6m
74	1	EW (Buildings)	SINGLE	0.900	58.5w LED 4000k Via City Flood 585mA with FW70 Optic wall mounted at 6m
45	1	F (Site Gates)	SINGLE	0.900	15w LED Flood Wall Flood mounted at 3.5m
12	1	G2	TWIN 25 DEGREE	0.900	2 x 117.6w LED 4000k Via City Flood 780mA with FL50 Optic column mounted at 6m
12	1	Z1	SINGLE	0.900	1300w Area Flood with NS1 Optic column mounted at 12m
28	1	H (House Blocks)	SINGLE	0.900	117.6w LED 4000k Via City Flood 780mA with FW70 Optic mounted on top of house blocks at 12.5m
29	1	I (Fence)	SINGLE	0.900	52w (1 module) 700mA labe 1 with ASP 12w Optic fence mounted at 6m

© Crown copyright 2018
 Do not scale from drawings. Verify all dimensions on site prior to construction. This drawing is to be read in conjunction with all relevant documents and drawings. Report all discrepancies to MUI immediately.
 No unauthorised use, disclosure, storage or copying.
 Notes

- To be read in conjunction with 661277-0000-PEV-GTX0011-ZZ-DR-E-6311 External Lighting Report

FOR CONTINUATION, PLEASE SEE DWG: 661277-0000-PEV-GTX0011-ZZ-DR-E-6311

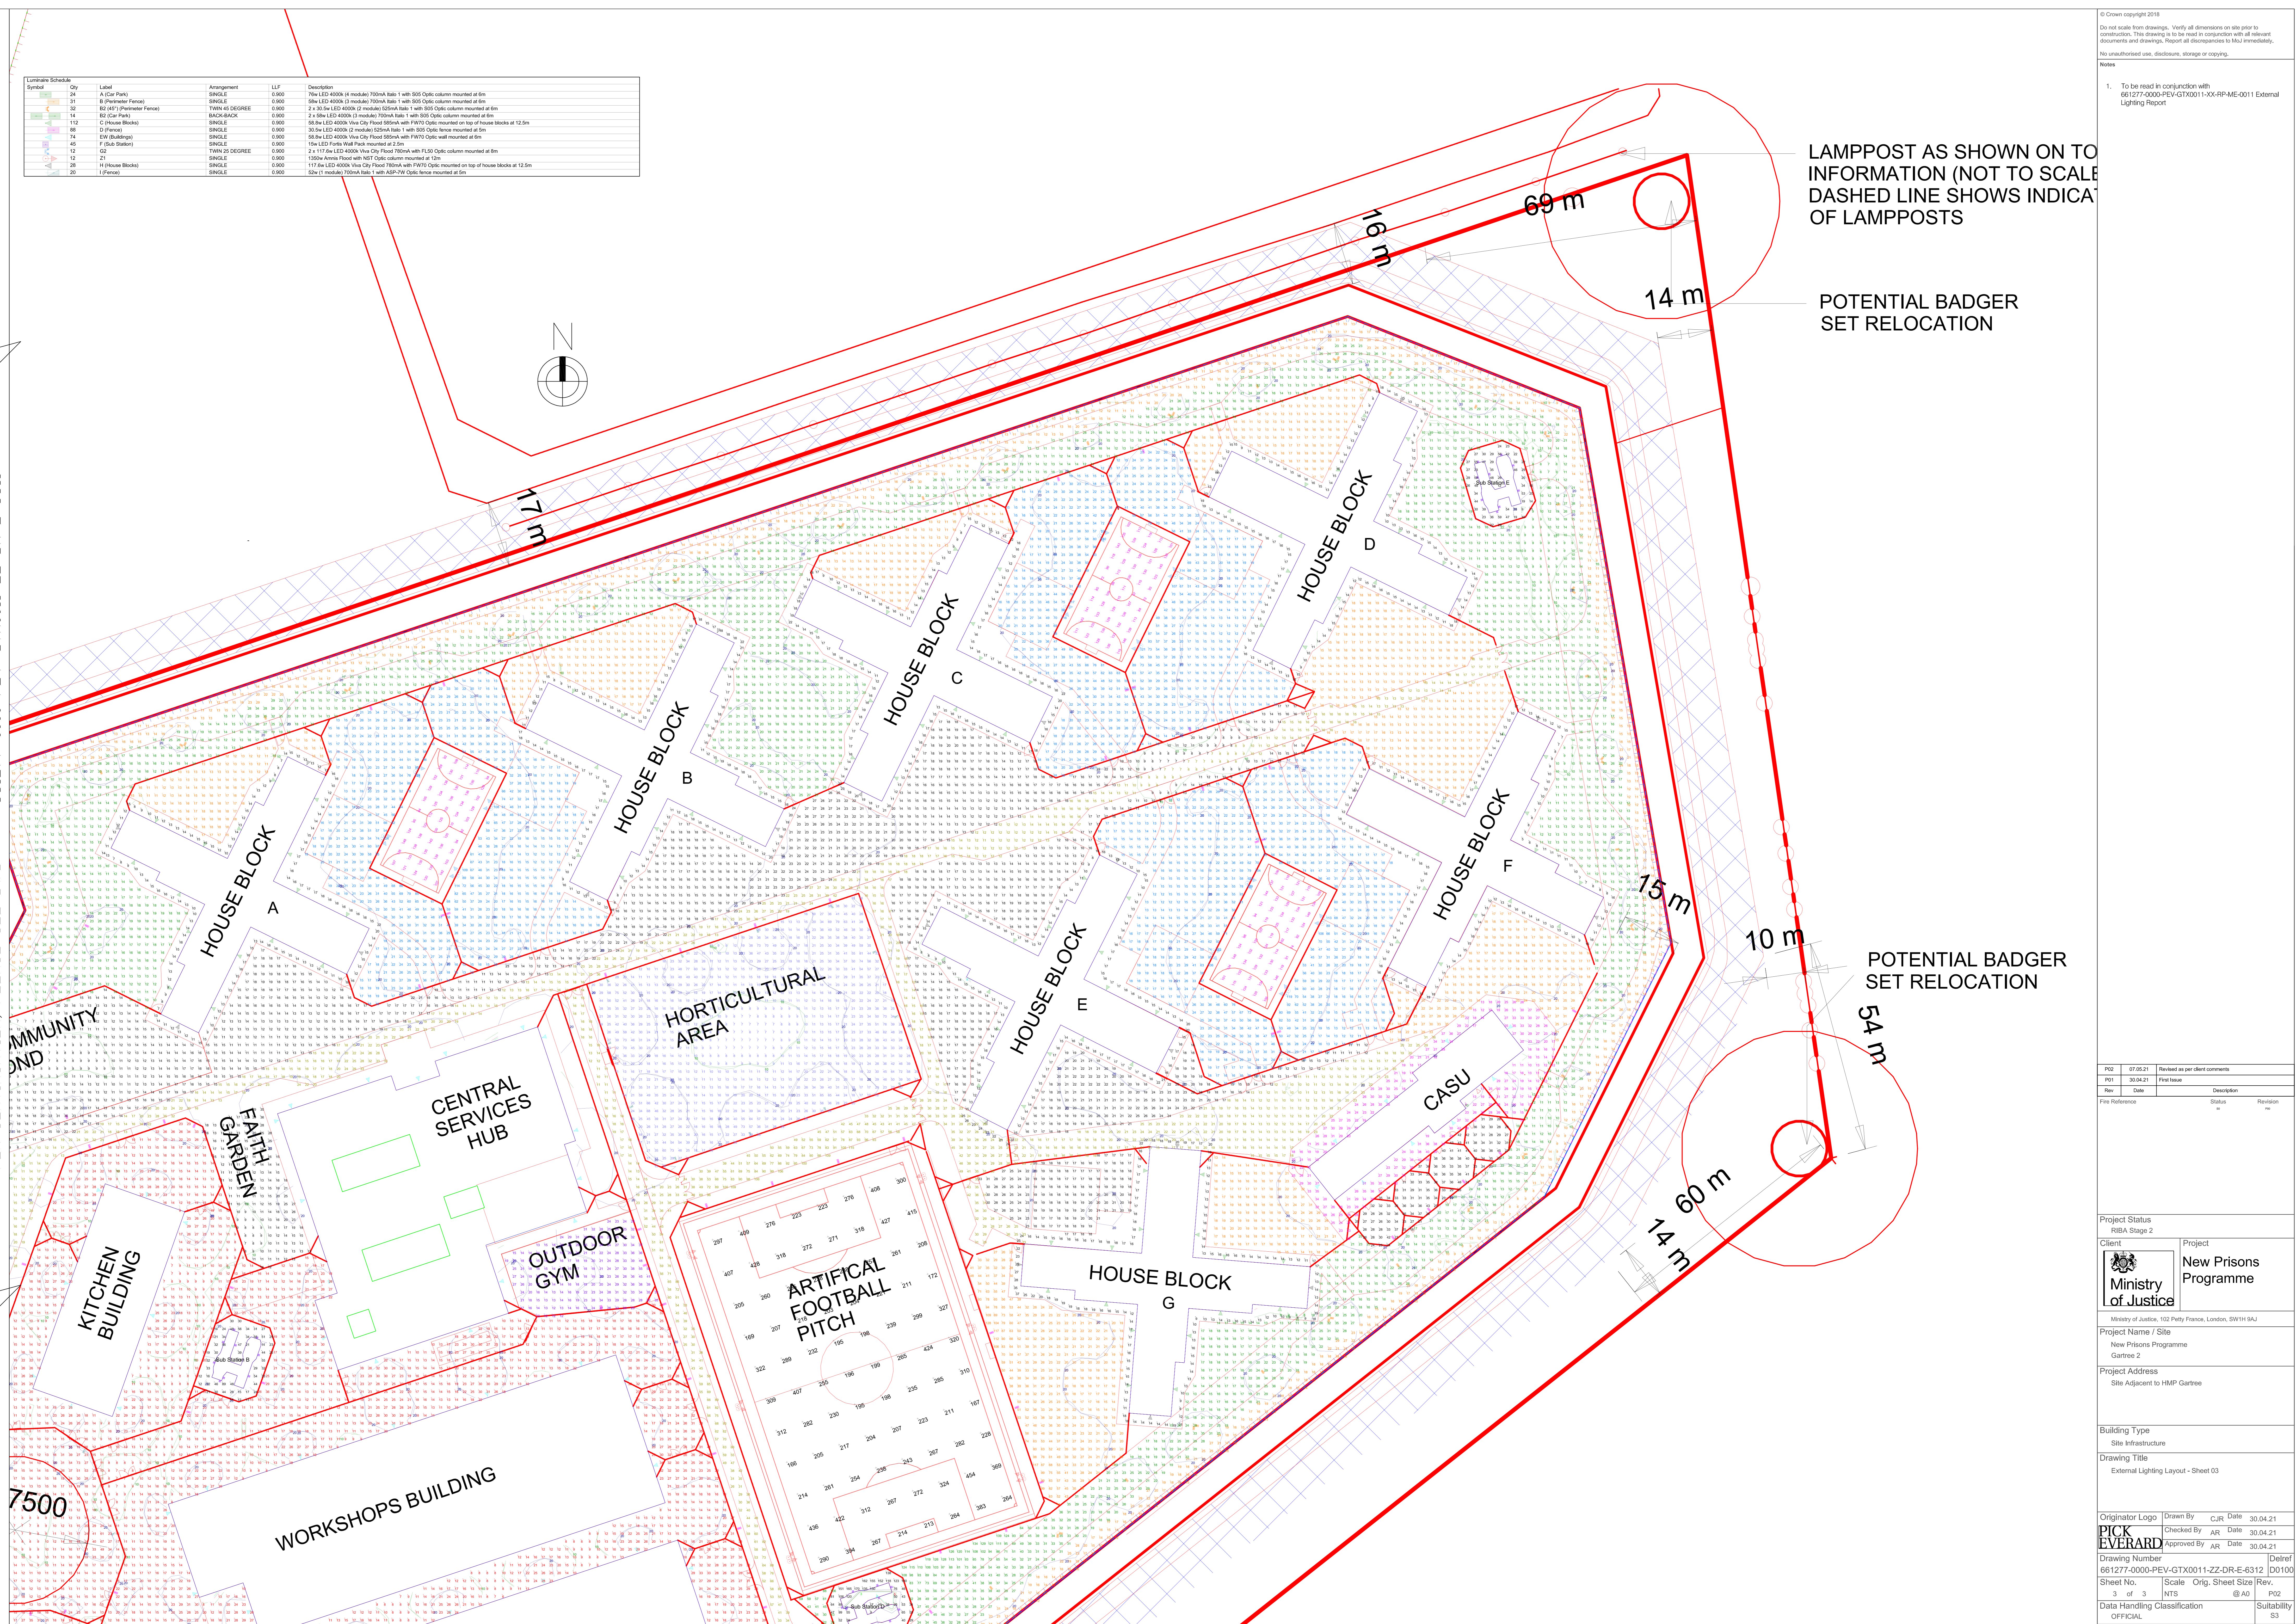

LAMPPOST AS SHOWN ON TO INFORMATION (NOT TO SCALE)
 DASHED LINE SHOWS INDICAT OF LAMPPOSTS

POTENTIAL BADGER SET RELOCATION

POTENTIAL BADGER SET RELOCATION

Rev	Date	Description	Revision #
P02	07.05.21	Revised as per client comments	
P01	30.04.21	First Issue	

Project Status
RIBA Stage 2

Client
Project
Ministry of Justice
New Prisons Programme

Project Name / Site
New Prisons Programme
Garstree 2

Project Address
Site Adjacent to HMP Garstree

Building Type
Site Infrastructure

Drawing Title
External Lighting Layout - Sheet 03

Originator Logo
PICK EVERARD

Drawn By: CJR Date: 30.04.21
 Checked By: AR Date: 30.04.21
 Approved By: AR Date: 30.04.21

Drawing Number
661277-0000-PEV-GTX0011-ZZ-DR-E-6312 D0100

Sheet No. 3 of 3 Scale: NTS Orig. Sheet Size: @A0 Rev: P02

Data Handling Classification: OFFICIAL Suitability: 53