


Symbol	Qty	Label	Arrangement	LF	Description
14	1	A (Car Park)	SINGLE	0.000	700x LED 4000k (4 module) 700mA Halo 1 with 505 Optic column mounted at 6m
31	1	B (Perimeter Fence)	SINGLE	0.000	58w LED 4000k (3 module) 700mA Halo 1 with 505 Optic column mounted at 6m
32	1	B2 (Perimeter Fence)	TWIN 25 DEGREE	0.000	2 x 30.5w LED 4000k (2 module) 505mA Halo 1 with 505 Optic column mounted at 6m
14	1	B3 (Car Park)	BACK-2-BACK	0.000	2 x 58w LED 4000k (3 module) 700mA Halo 1 with 505 Optic column mounted at 6m
112	1	C (House Blocks)	SINGLE	0.000	58.6w LED 4000k Via City Flood 580mA with FWT0 Optic mounted on top of house blocks at 12.5m
88	1	D (Fence)	SINGLE	0.000	30.5w LED 4000k (2 module) 505mA Halo 1 with 505 Optic fence mounted at 6m
74	1	E (Buildings)	SINGLE	0.000	58.6w LED 4000k Via City Flood 580mA with FWT0 Optic mounted at 6m
43	1	F (Bus Station)	SINGLE	0.000	150w LED Flood Wall Flood mounted at 3.0m
12	1	G2	TWIN 25 DEGREE	0.000	2 x 117.6w LED 4000k Via City Flood 700mA with FLS0 Optic column mounted at 6m
12	1	G1	SINGLE	0.000	1300w Area Flood with N67 Optic column mounted at 12m
28	1	H (House Blocks)	SINGLE	0.000	117.6w LED 4000k Via City Flood 700mA with FWT0 Optic mounted on top of house blocks at 12.5m
20	1	I (Fence)	SINGLE	0.000	52w (1 module) 700mA Halo 1 with ASDA-FW Optic fence mounted at 5m

© Crown copyright 2018  
 Do not scale from drawings. Verify all dimensions on site prior to construction. This drawing is to be read in conjunction with all relevant documents and drawings. Report all discrepancies to MUI immediately.  
 No unauthorised use, disclosure, storage or copying.  
 Notes  
 1. To be read in conjunction with 661277-0000-PEV-GTX0011-KX-PP-AME-0011 External Lighting Report.

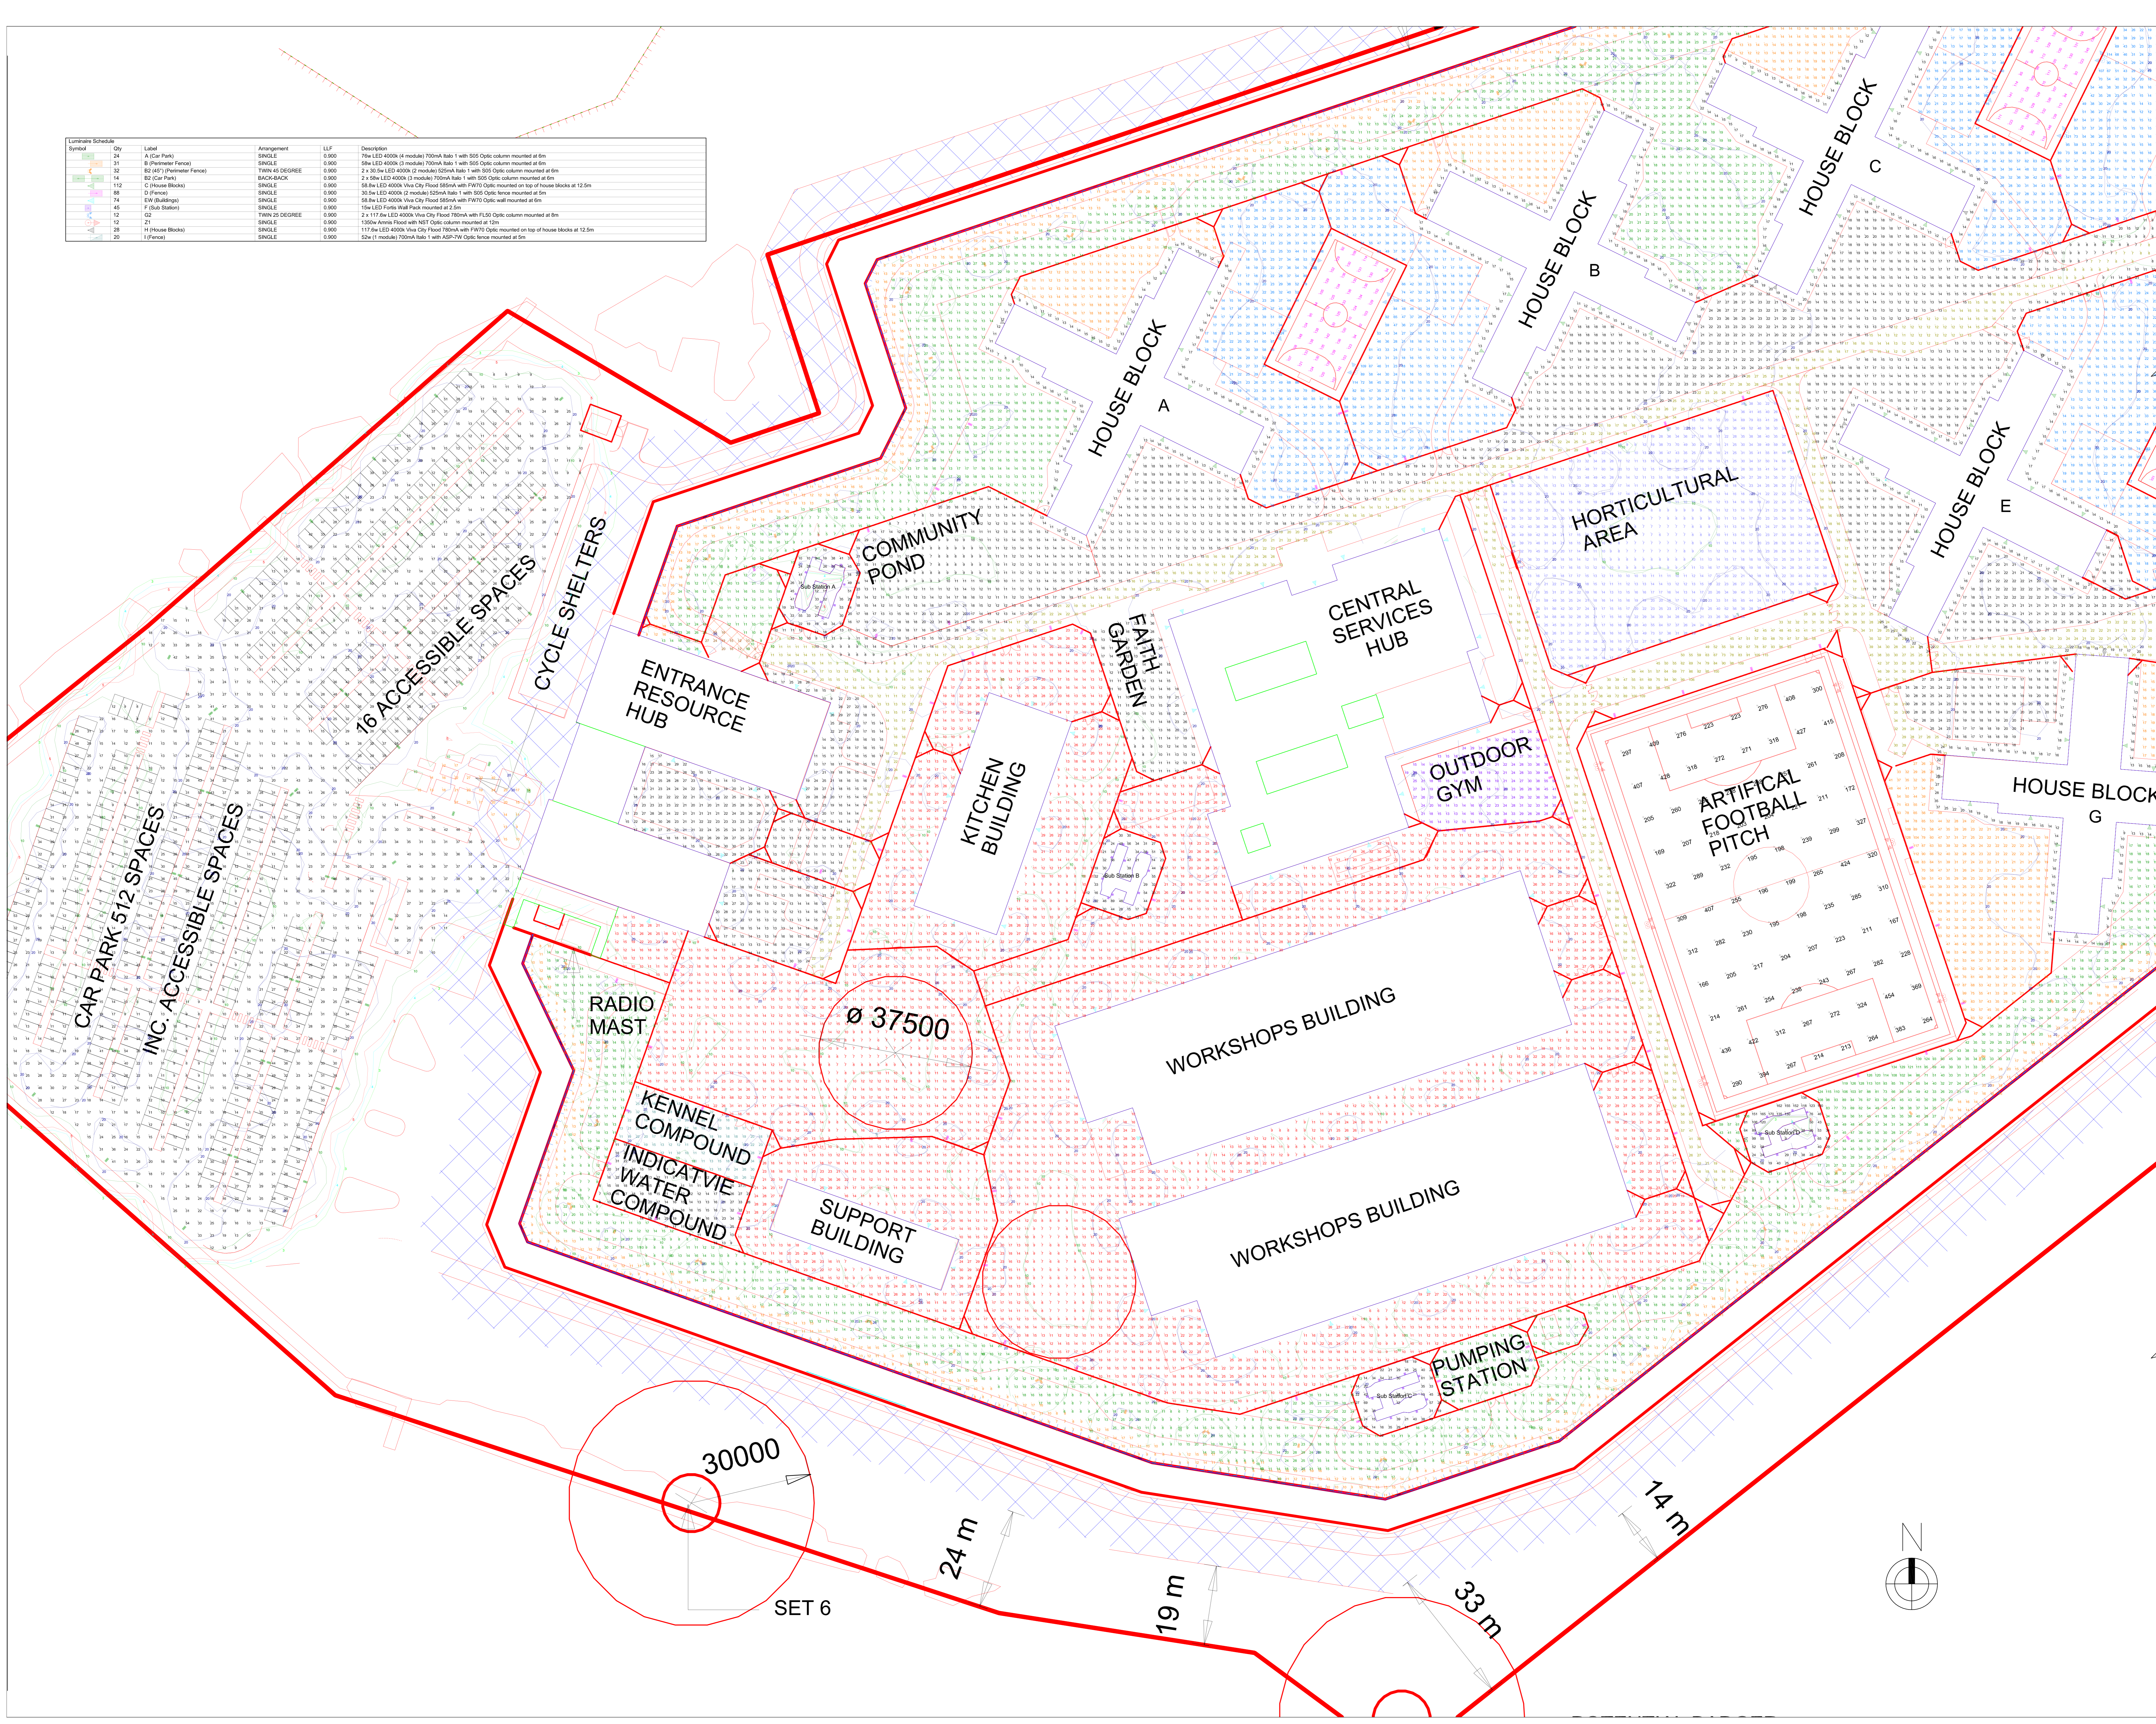

FOR CONTINUATION, PLEASE SEE DWG: 661277-0000-PEV-GTX0011-ZZ-DR-E-6312

Rev	Date	Description
P02	07.05.21	Revised as per client comments
P01	30.04.21	First Issue

File Reference	Status	Revision

Project Status  
RIBA Stage 2

Client  
 Ministry of Justice  
 Project  
 New Prisons Programme

Project Name / Site  
 New Prisons Programme  
 Gartree 2

Project Address  
 Site Adjacent to HMP Gartree

Building Type  
 Site Infrastructure

Drawing Title  
 External Lighting Layout - Sheet 02

Originator Logo <b>PICK EVERARD</b>	Drawn By CJR	Date 30.04.21
	Checked By AR	Date 30.04.21
	Approved By AR	Date 30.04.21
Drawing Number 661277-0000-PEV-GTX0011-ZZ-DR-E-6311	Delref D0100	
Sheet No. 2 of 3	Scale NTS	Orig. Sheet Size @A0
Data Handling Classification OFFICIAL	Suitability P02	Rev. 53